


Luminaire Schedule											
Symbol	Label	Quantity	Manufacturer	Catalog Number	Description	Lamp	Number Lamps	Filename	Lumens Per Lamp	Light Loss Factor	Wattage
	ZA	19	Lithonia Lighting	AS1 LED 42C 700 40K SR3 MVOLT	AS1 AREA LIGHT 42 LEDs 700 mA DRIVE CURRENT 40K COLOR TEMP TYPE 3 DISTRIBUTION	HLM LIGHT ENGINE	1	AS1_LED_42C_700_40K_SR3_MVOLT.ies	8532	0.92	97
	ZB	8	Lithonia Lighting	AS1 LED 42C 700 40K SR4 MVOLT	AS1 AREA LIGHT 42 LEDs 700 mA DRIVE CURRENT 40K COLOR TEMP TYPE 4 DISTRIBUTION	HLM LIGHT ENGINE	1	AS1_LED_42C_700_40K_SR4_MVOLT.ies	8475	0.92	97

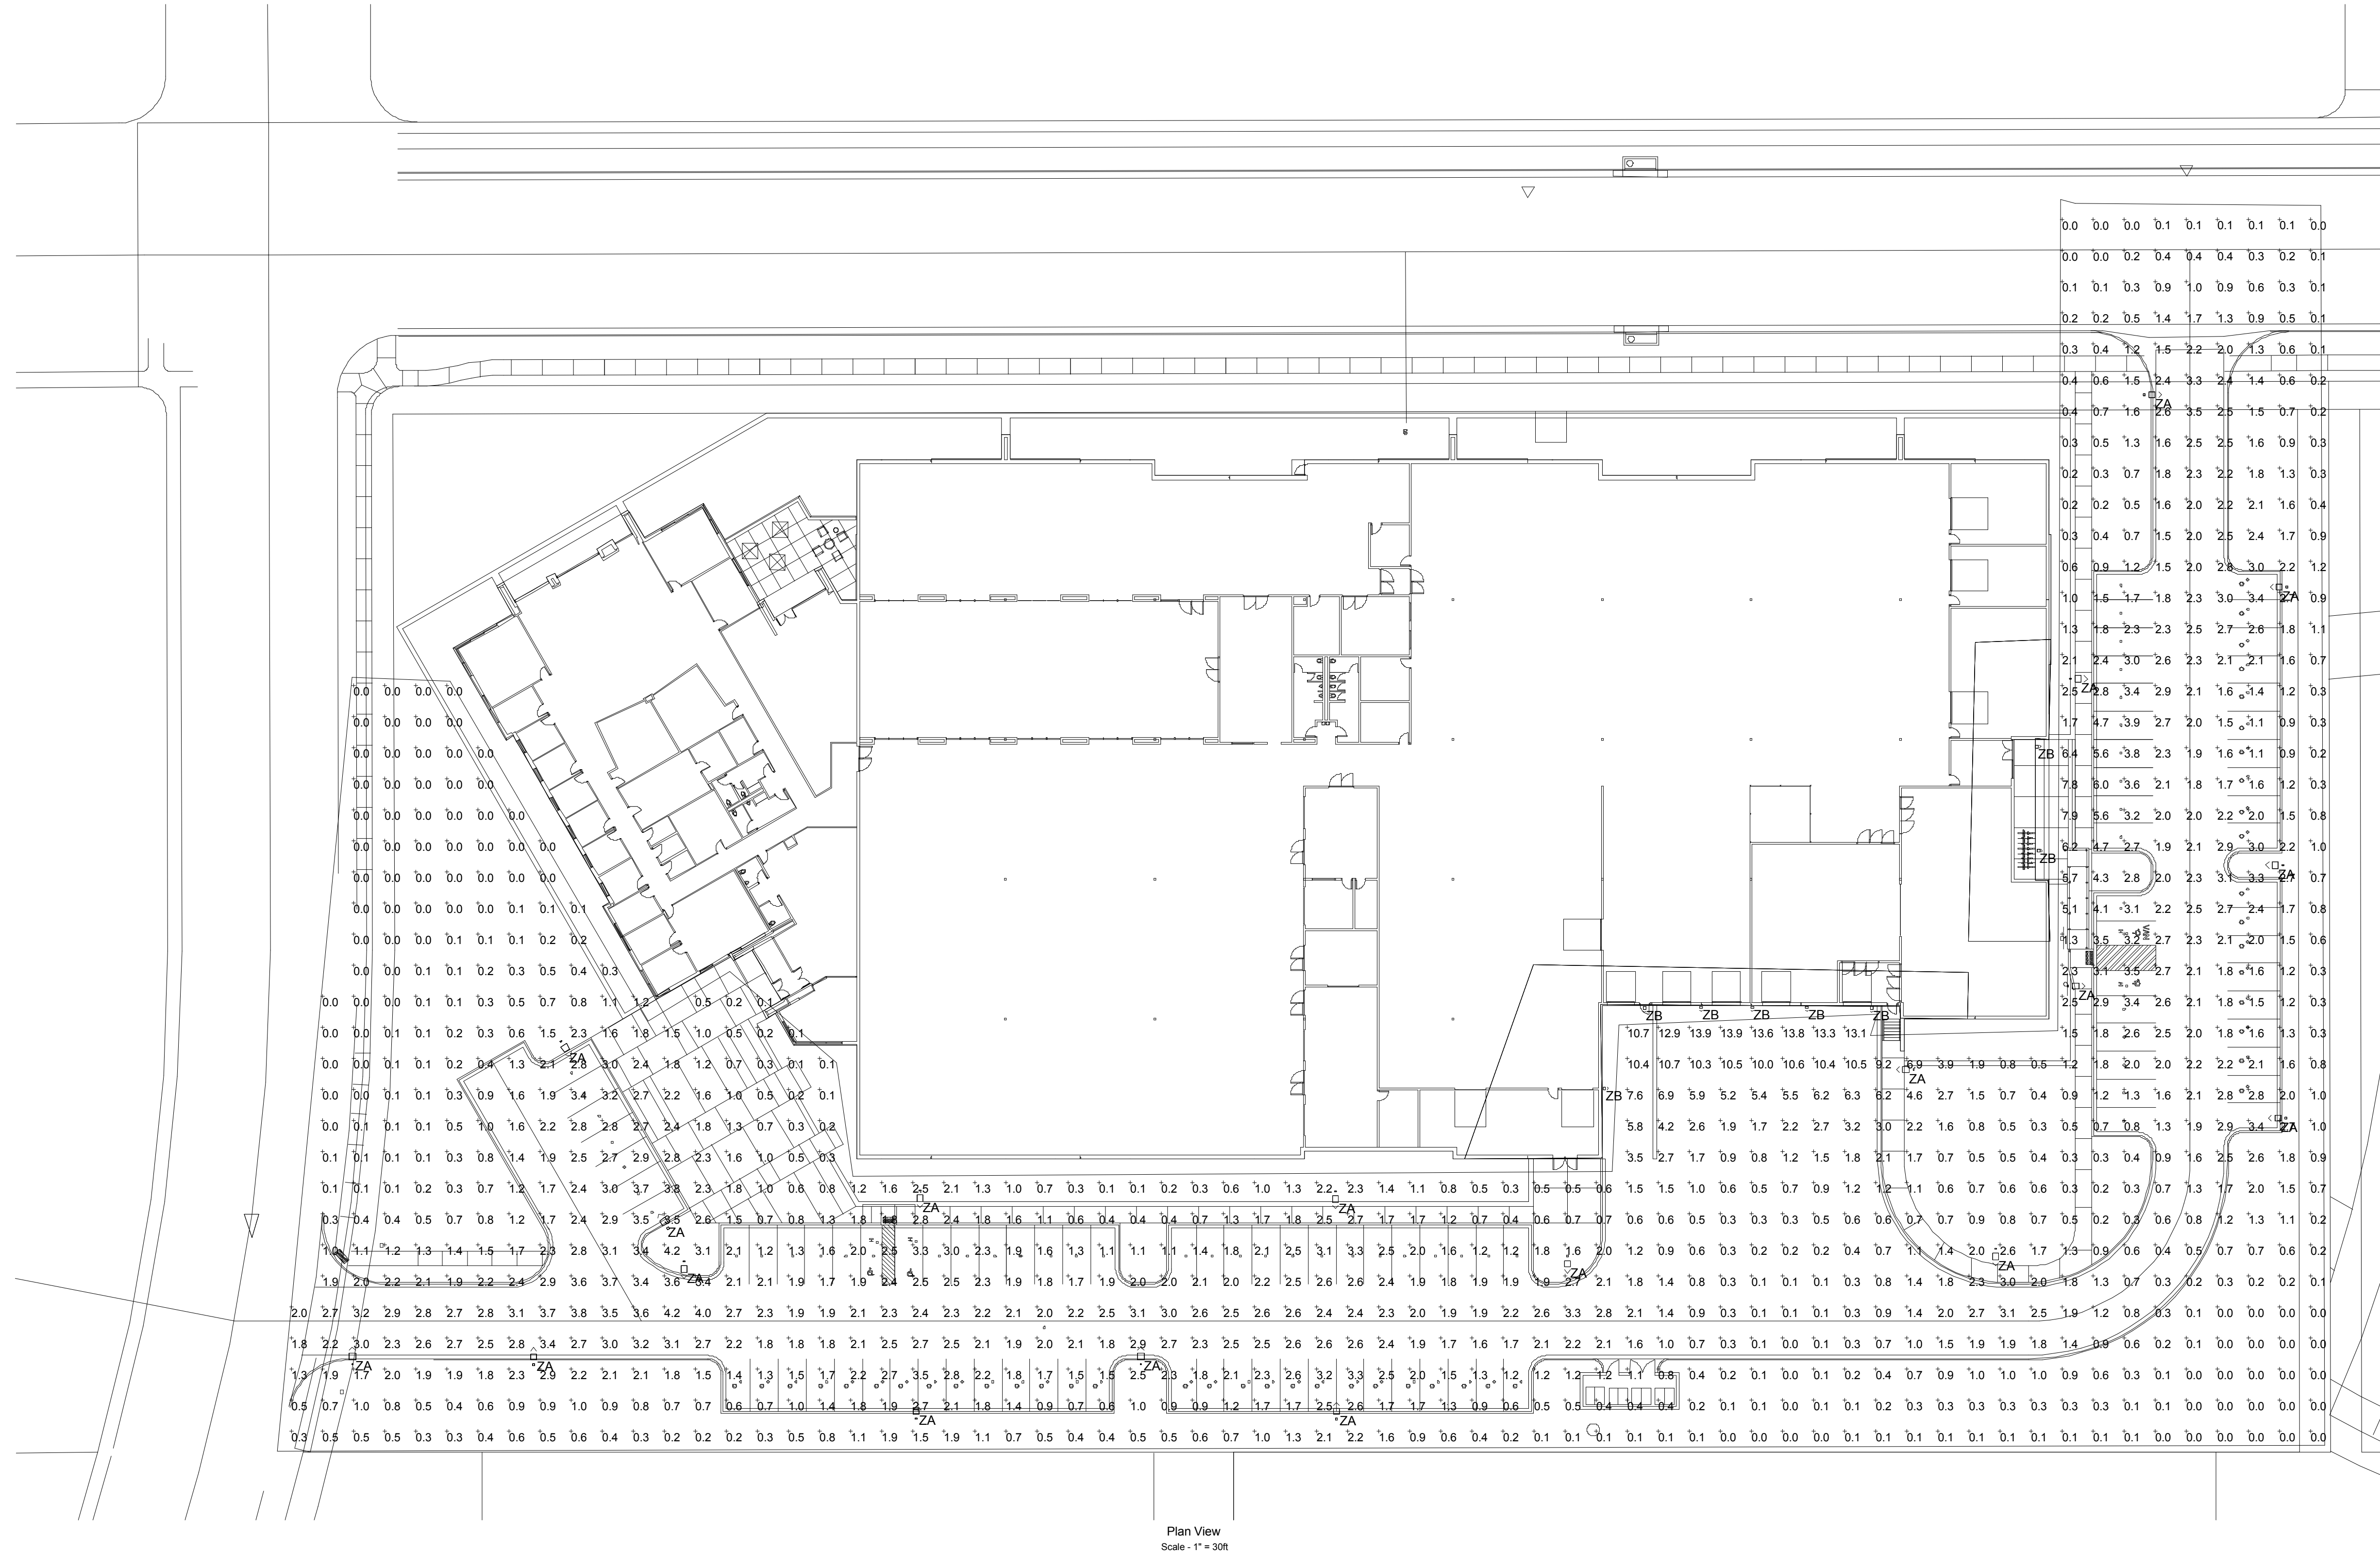

PROJECT:
WILMARC MEDICAL

HARMONY TECHNOLOGY PARK

SEAL:

PRELIMINARY DEVELOPMENT PLAN

PROJECT NO: 16-406
DRAWN BY: BCER
CHECKED BY: BCER

ISSUE AND REVISION SCHEDULE:

DRAWING TITLE:
LIGHTING PLAN

SHEET:

PH001

