


03110124

STR-LWY-3M-HT - Type III Medium

Detailed Catalog #: STR-LWY-3M-HT

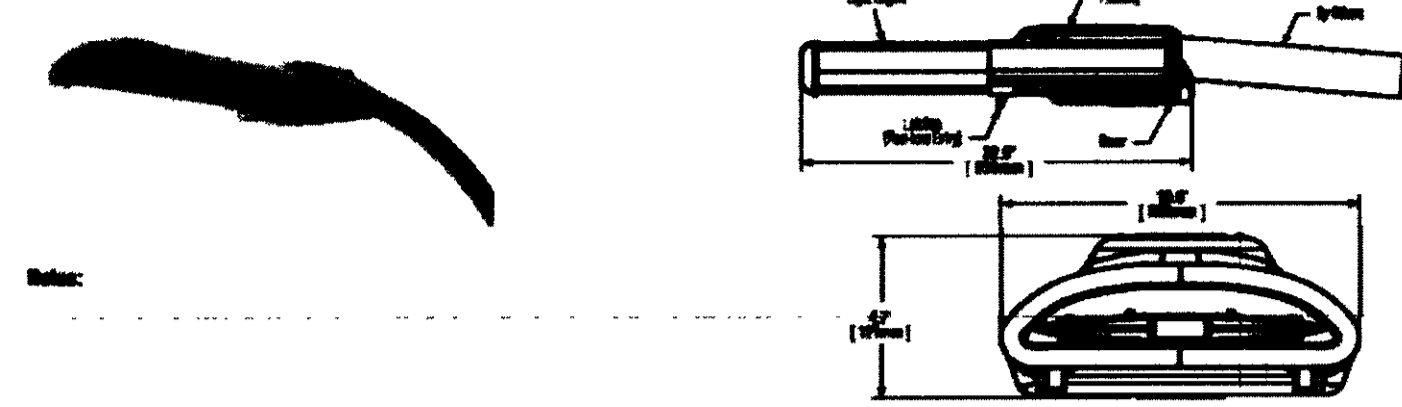


NOTE: ALL LIGHT FIXTURES SHALL BE ATTACHED TO POLES OR BUILDING BY USE OF NON ADJUSTABLE ANGLE BRACKETS OR WALL MOUNT BRACKETS PER LUC 3.2.4 (D).

Luminaire Schedule							
Symbol	Qty	Label	Arrangement	Total Lamp Lumens	LLF	Description	Total Watts
☐	1	LWY-3M-90	2 @ 90 DEGREES	10162	0.940	STR-LWY-3M-HT-08-D-UL-BZ-525mA	270
◀	11	SEC-3M-02	SINGLE	2539	0.940	SEC-ARE-3M-WM-02-D-UL-BZ-525mA	407

Footcandle calculated using predicted lumen values after 50K hours of operation					
Label	Avg	Max	Min	Avg/Min	Max/Min
GRADE	0.60	5.0	0.0	N/A	N/A

 SCALE



ROTH ENGINEERING GROUP, LLC

21763 UNBRIDLED AVENUE
PARKER, CO 80138
PHONE: 303-841-9365
FAX: 303-848-5212


PROSPECT 7-ELEVEN STORE NO. 35506

PREPARED FOR:
1121 GRANT STREET DENVER, CO 80205

03110109


THE EDGE LED WALL PACK

Detailed Catalog #: SEC-EDG-3M-WM


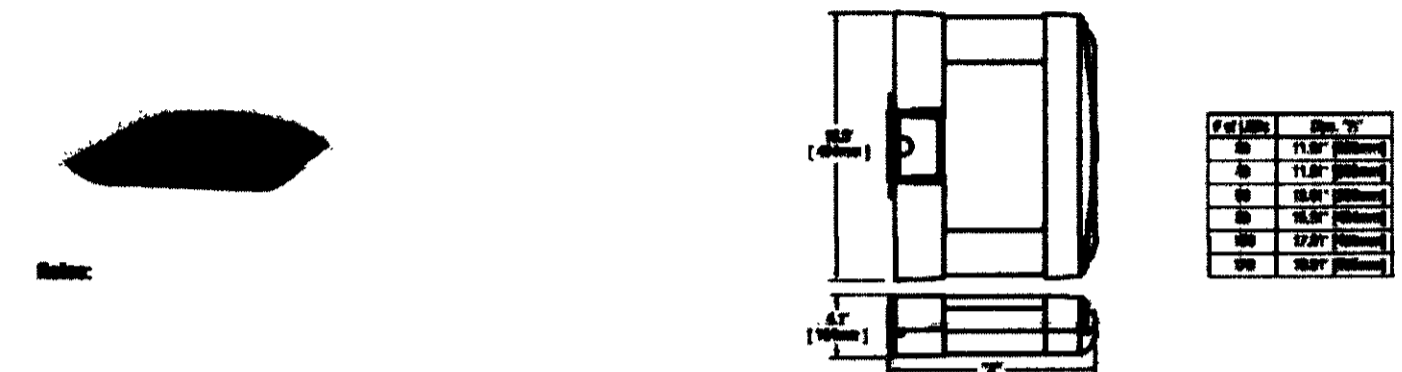


Super-Dimmed Mount Horizontal Tenon


Base Catalog Number:

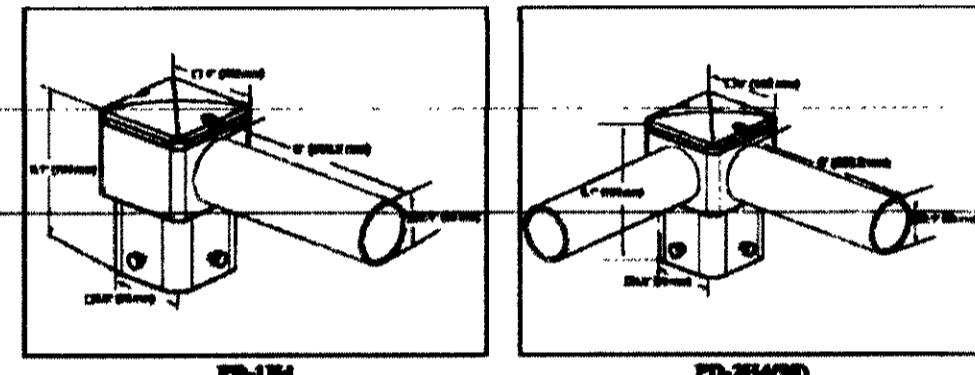

BETA EDGE WALL MOUNT SECURITY LIGHT

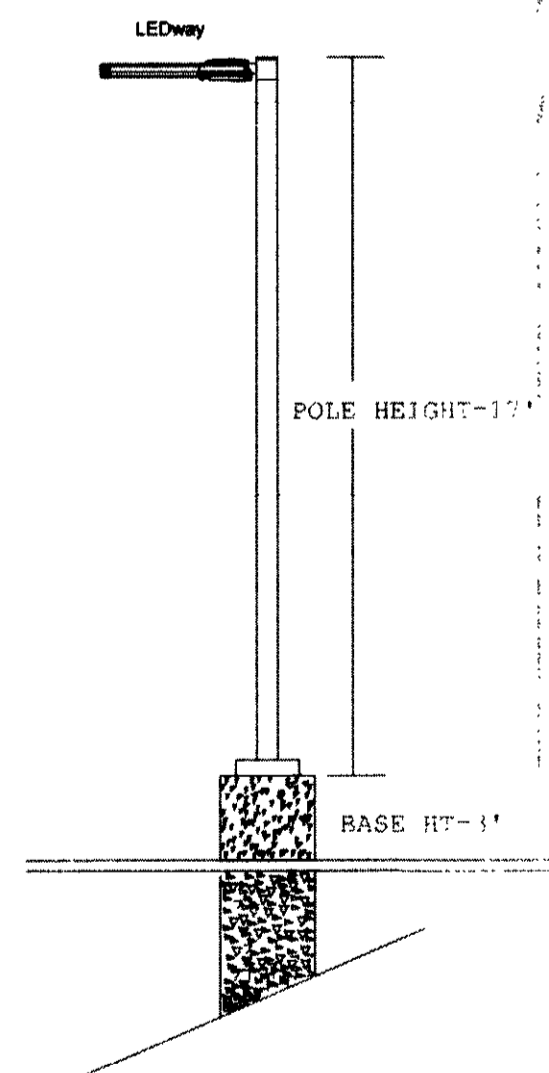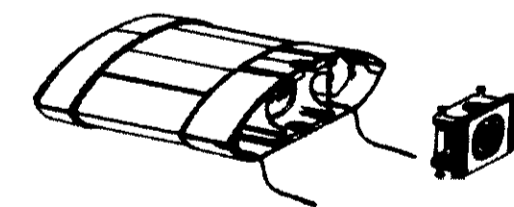

ADDITIONAL EQUIPMENT
(3) PS4S17CTBZ 17 x 4 x .125" SQUARE STEEL POLE
(2) PD-1H4 SINGLE TENON
(1) PD-2H4(90) SINGLE TENON
POLE AND FIXTURE MEETS 140 MPH SUSTAINED WINDS

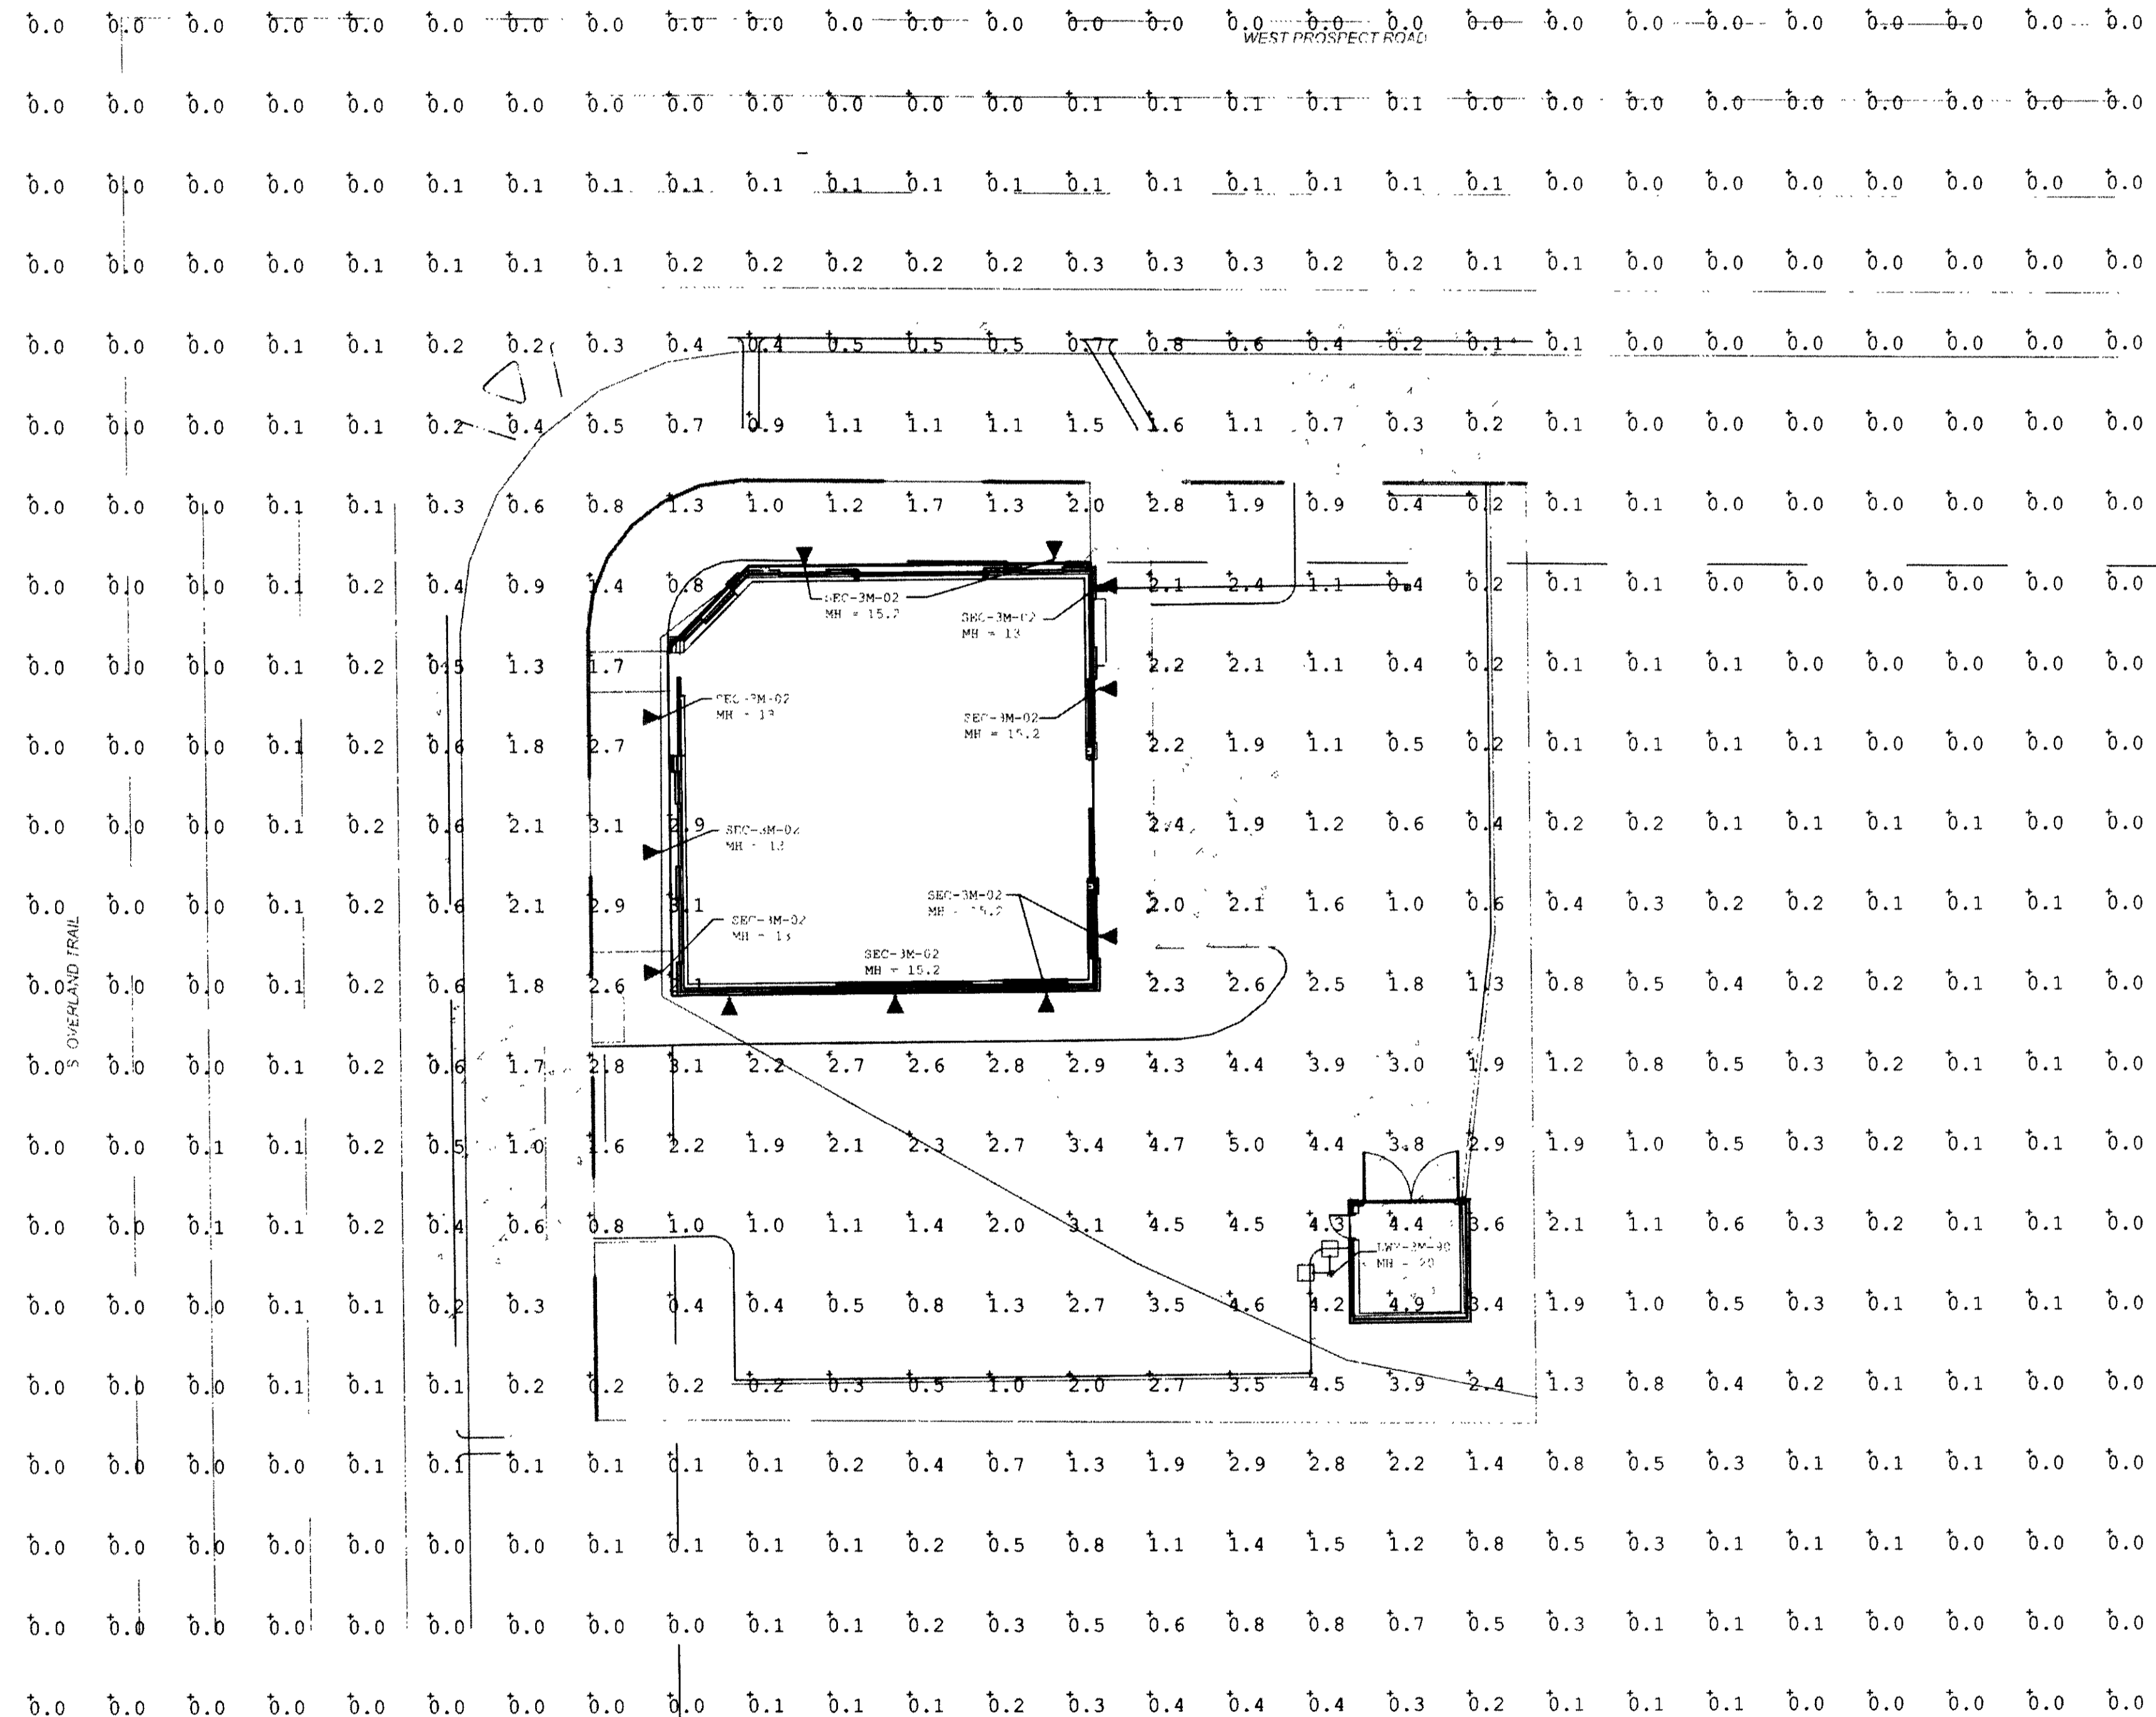

PHOTOMETRIC PLAN

SHEET NUMBER:
1 OF 1