

1 SITE LIGHTING PLAN
1"=20'-0"

UCM - Universe Medium Housing Scale

1. LUMINAIRE
 LUMINAIRE
 LUMINAIRE AND/OR

2. LUMINAIRE HODD
 HODD
 HODD AND/OR

3. OPTICS
 OPTICS
 OPTICS AND/OR

4. LAMP/BALLAST
 LAMP/BALLAST
 LAMP/BALLAST AND/OR


5. COLOR
 COLOR
 COLOR AND/OR

6. OPTIONS
 OPTIONS
 OPTIONS AND/OR

7. FINISH
 FINISH
 FINISH AND/OR

8. MOUNTING
 MOUNTING
 MOUNTING AND/OR

9. TYPE
 TYPE
 TYPE AND/OR

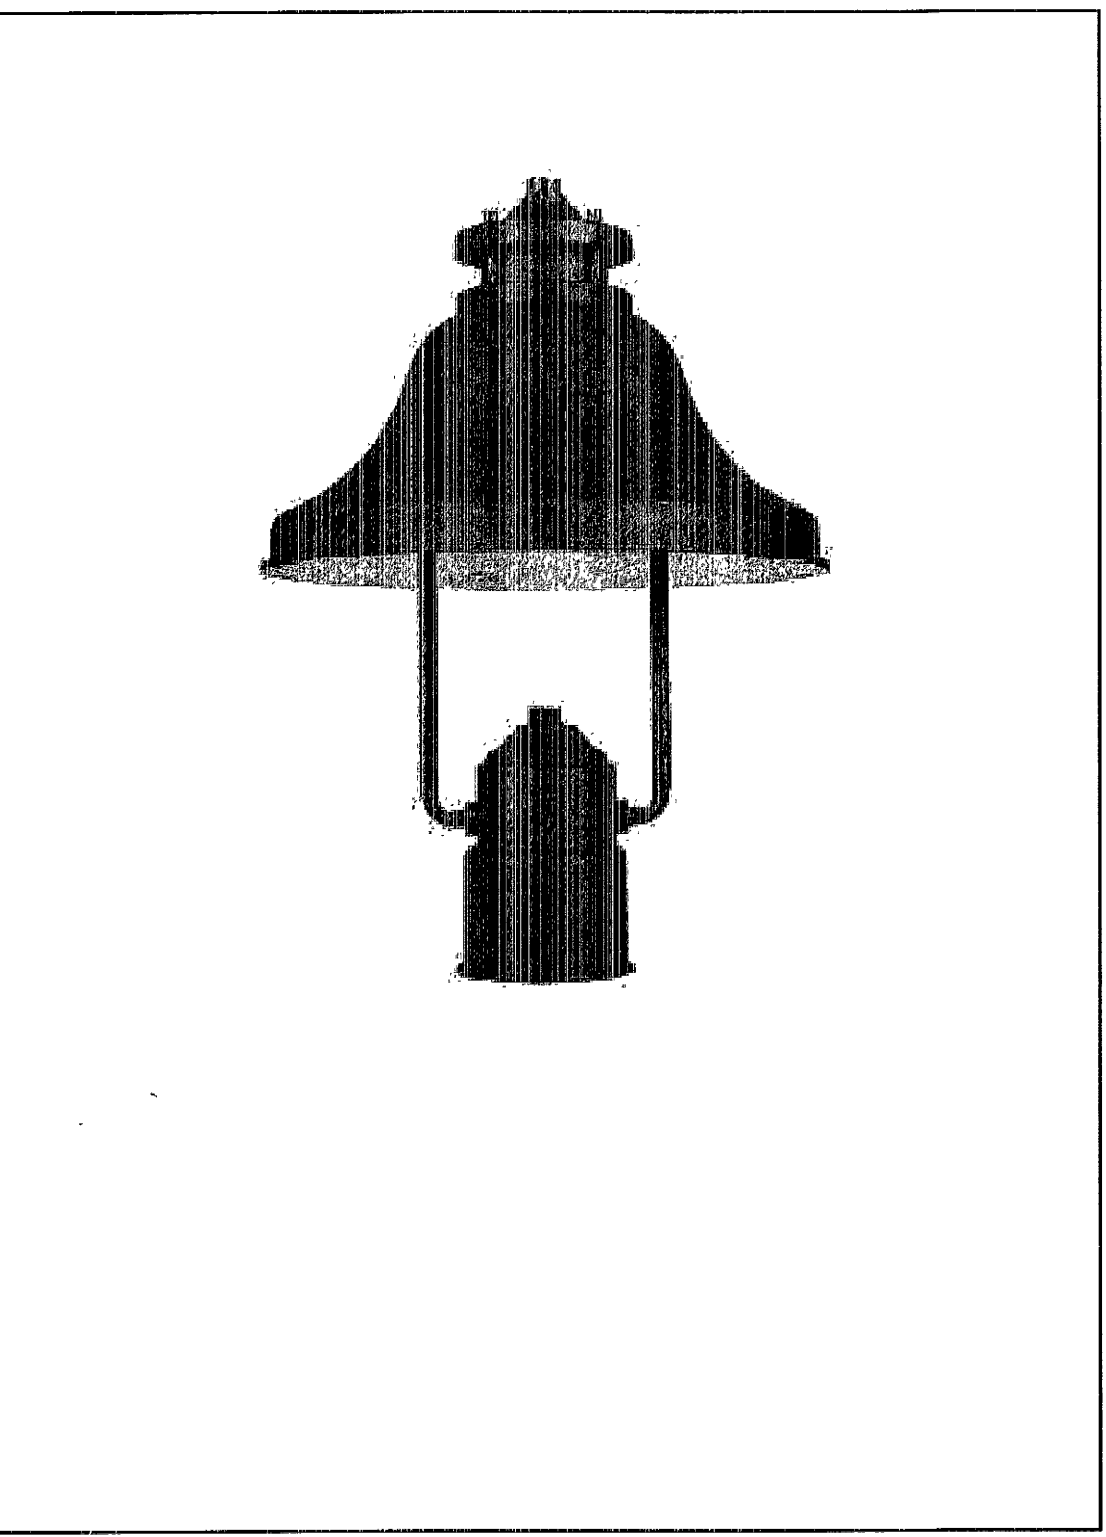

3 FIXTURE TYPE "SB"
NONE

QSPC QUARTER SPHERE COMPACT ARCHITECTURAL WALLFIX

1. LUMINAIRE
 LUMINAIRE
 LUMINAIRE AND/OR

2. LUMINAIRE HODD
 HODD
 HODD AND/OR

3. OPTICS
 OPTICS
 OPTICS AND/OR

4. LAMP/BALLAST
 LAMP/BALLAST
 LAMP/BALLAST AND/OR


5. COLOR
 COLOR
 COLOR AND/OR

6. OPTIONS
 OPTIONS
 OPTIONS AND/OR

7. FINISH
 FINISH
 FINISH AND/OR

8. MOUNTING
 MOUNTING
 MOUNTING AND/OR

9. TYPE
 TYPE
 TYPE AND/OR

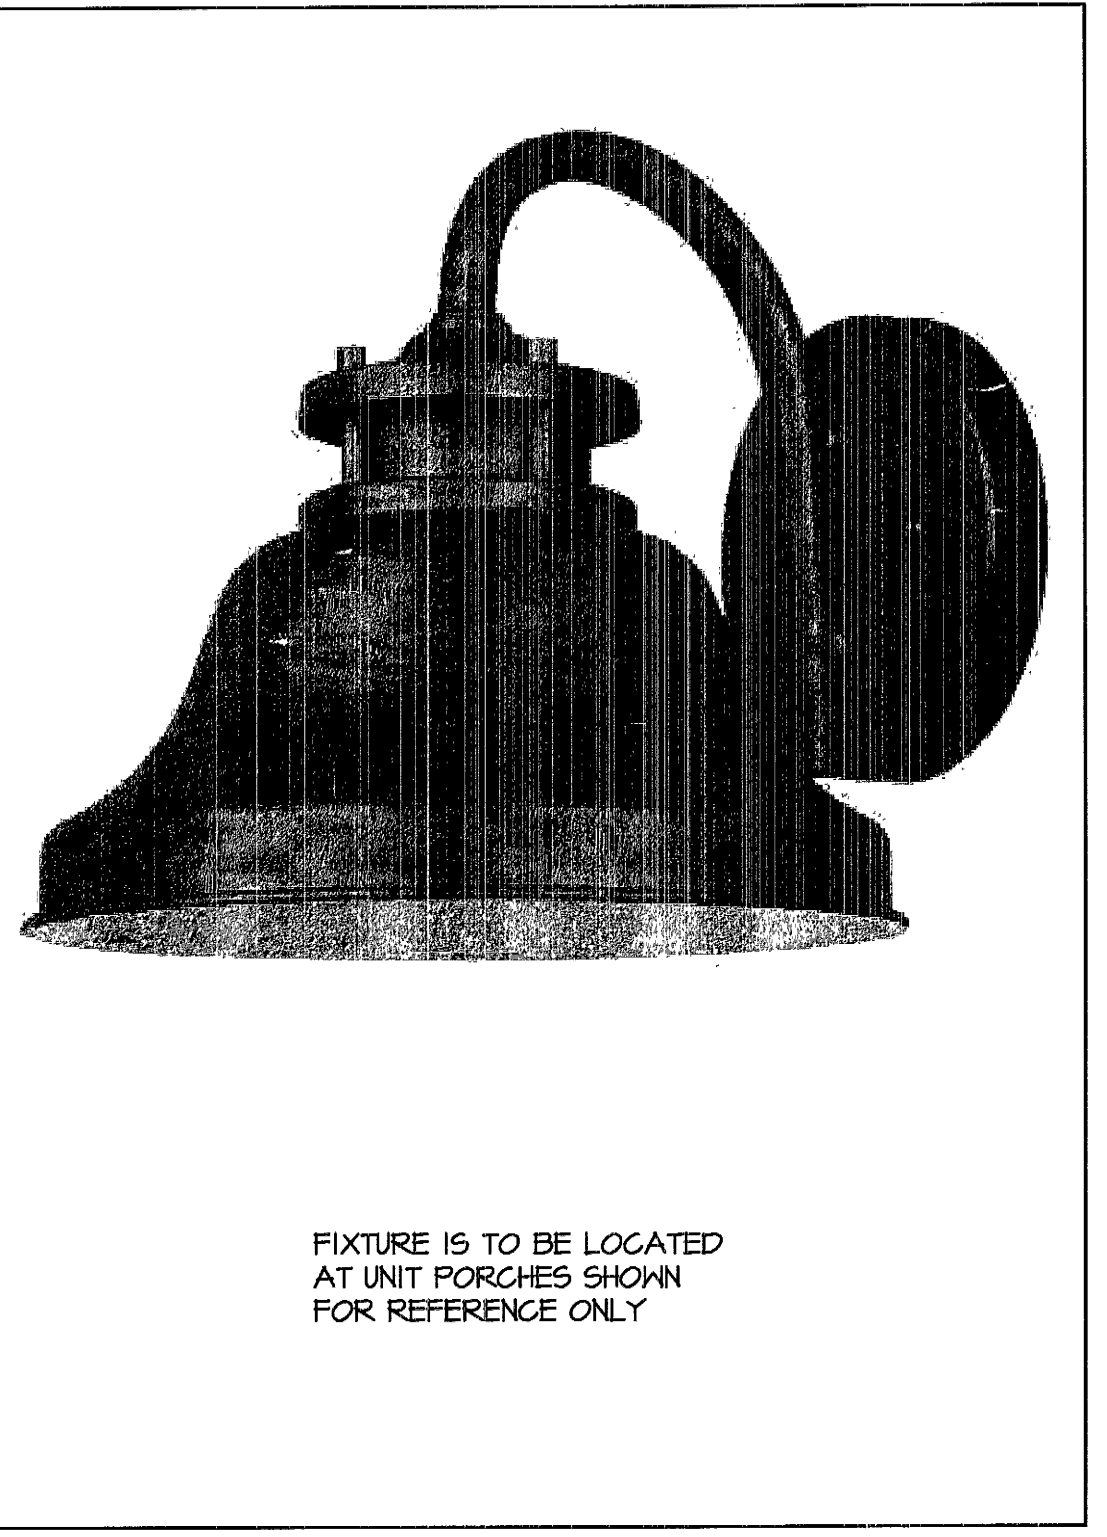

5 FIXTURE TYPE "SD"
NONE

J:\2012\2012-06-04-00\cad\elec\FP4.dwg Kevin 05.20.14 9:54 am