


Luminaire Schedule						
Project: All Projects						
Symbol	Qty	Label	Arrangement	Lumens	LLF	Description
	3	A	SINGLE	50000	0.800	GBM-3-400HPS
	1	B	D180	50000	0.800	2GBM-3-400HPS
	4	WP	SINGLE	16000	0.800	CHWS-3-150-HPS
	7	DL	SINGLE	8500	0.650	DOWN LIGHT

02 LUMINAIRE SCHEDULE

SCALE: N.T.S.

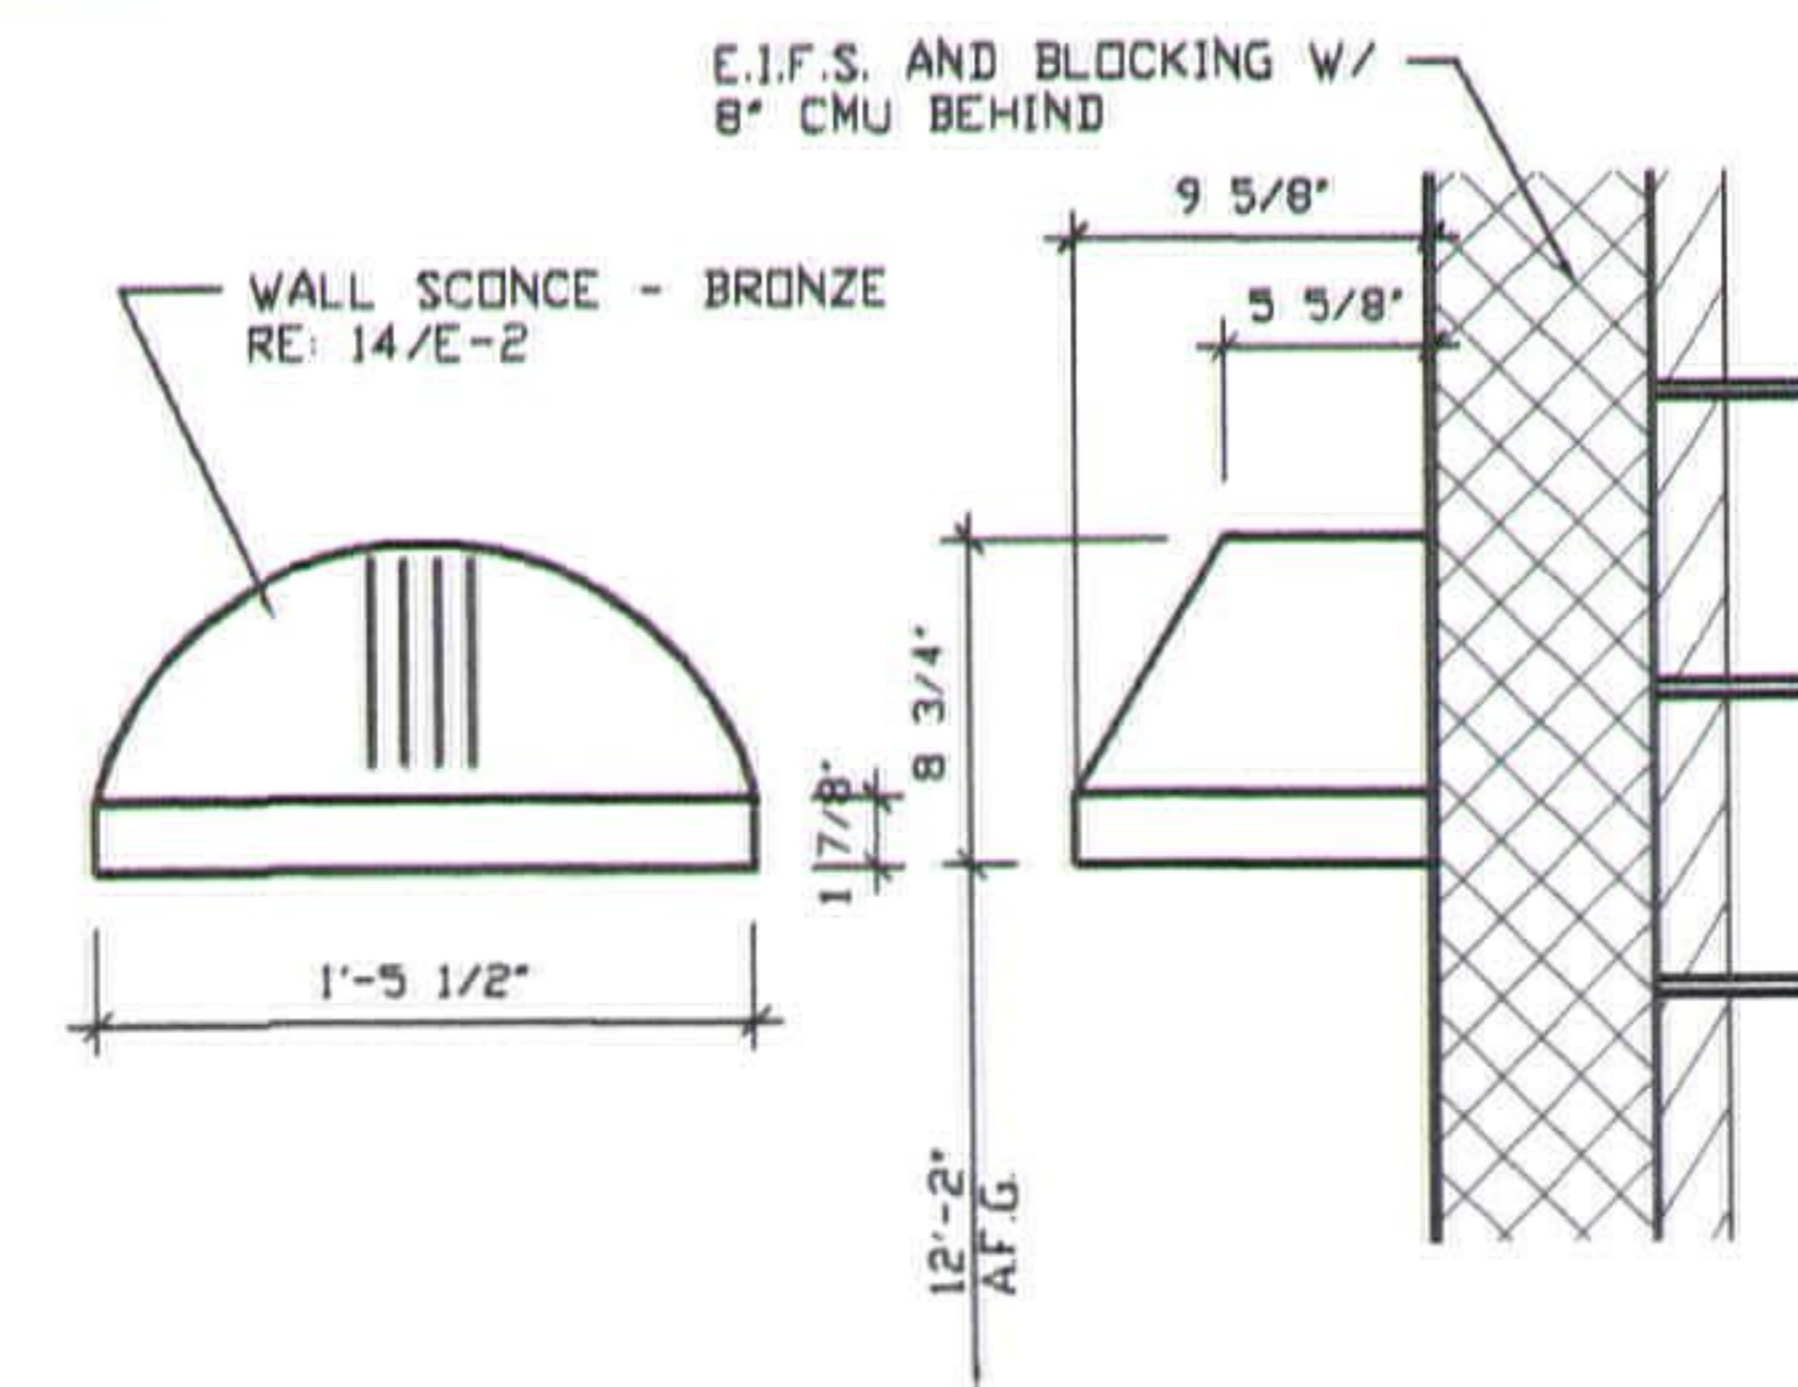

18 WALL SCONCE DETAIL

RE: 01/E-2

SCALE: 1 1/2"=1'-0"

WALL SCONCE
 CHWS (SMALL), TYPE III WIDE, (HPS)
 HIGH-PRESSURE SODIUM 150WATT, F-FLAT,
 NT-MULTI-TAP, BRONZE, TP-TAMPER PROOF

1 LIGHT + POLE
 GBM-ARM MOUNT, TYPE III, (HPS) HIGH-PRESSURE
 SODIUM 400WATT, CT-CONTOURED CLEAR
 TEMPERED GLASS, MT-MULTI-TAP, BLACK,
 NO-OPTIONS


2 LIGHT + POLE
 GBM-ARM MOUNT, TYPE III, (HPS)
 HIGH-PRESSURE SODIUM 400WATT,
 CT-CONTOURED CLEAR TEMPERED GLASS,
 NT-MULTI-TAP, BLACK, NO-OPTIONS

NOTE: ALL LIGHTS ARE LSI LIGHTINGS SYSTEMS

14 LIGHTING NOTES:

RE: E-2


SCALE: NONE

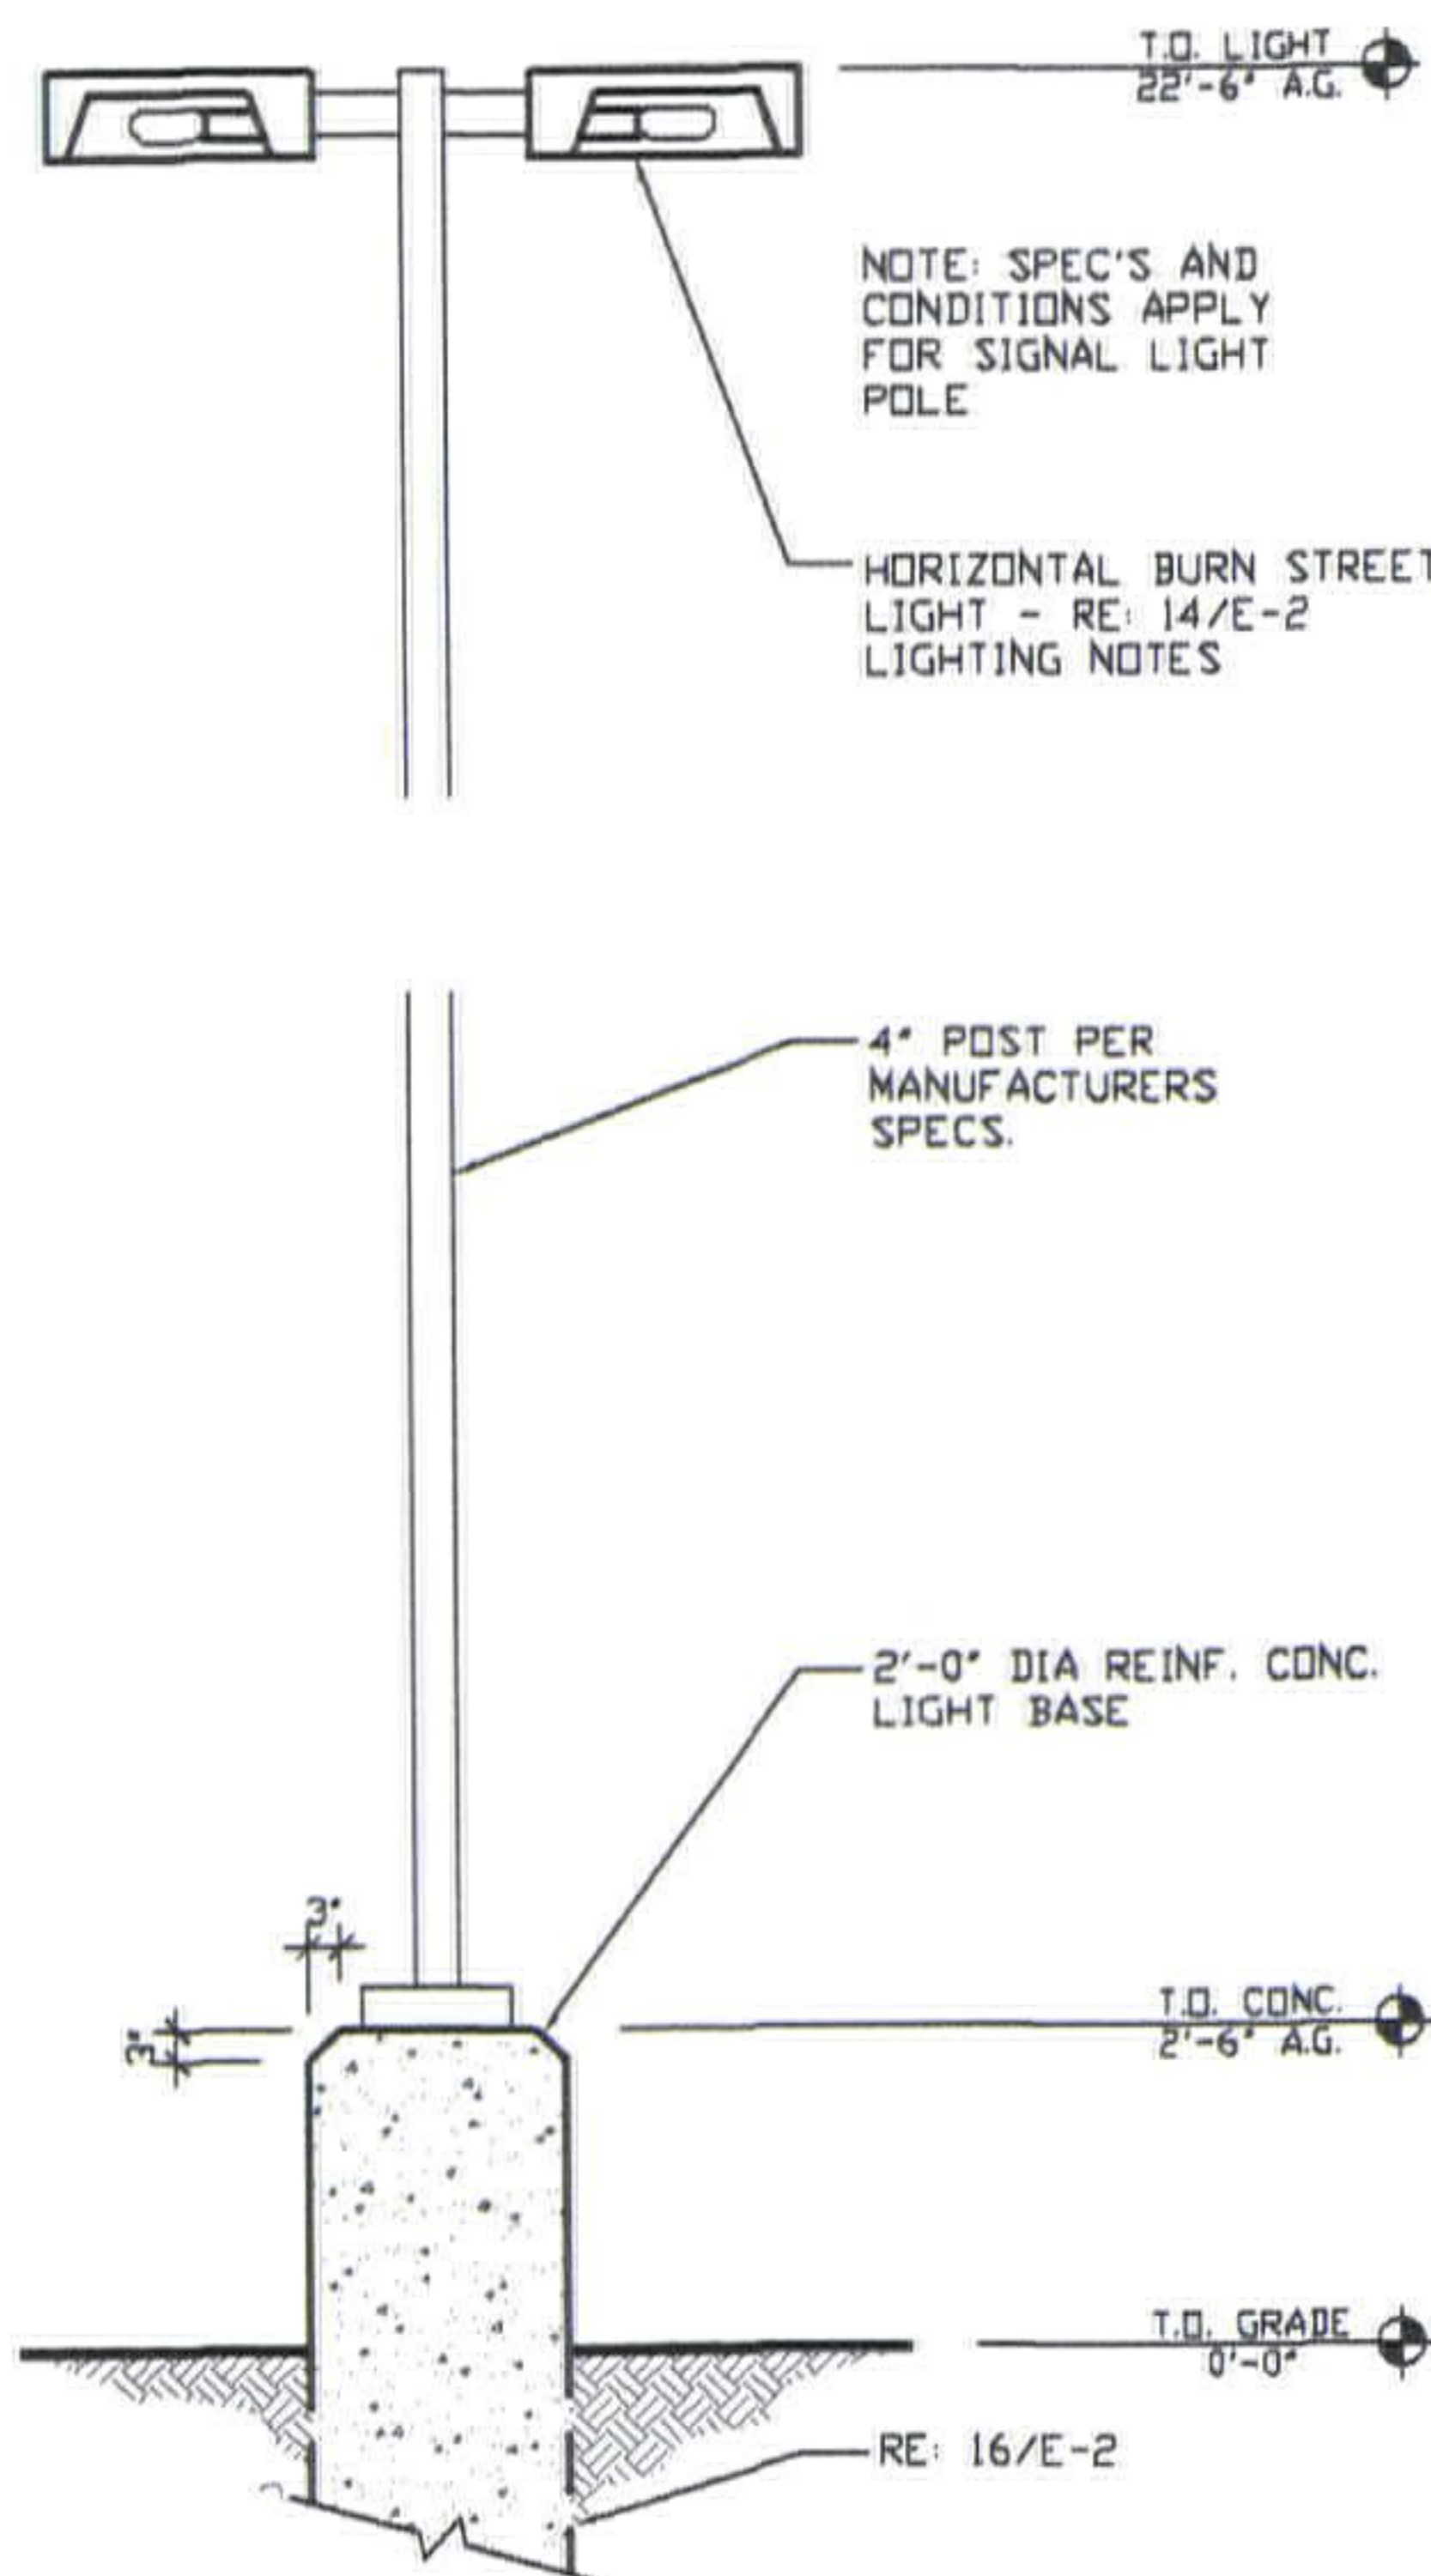

20 NAME

RE: 00/A0.0

SCALE: SCALE

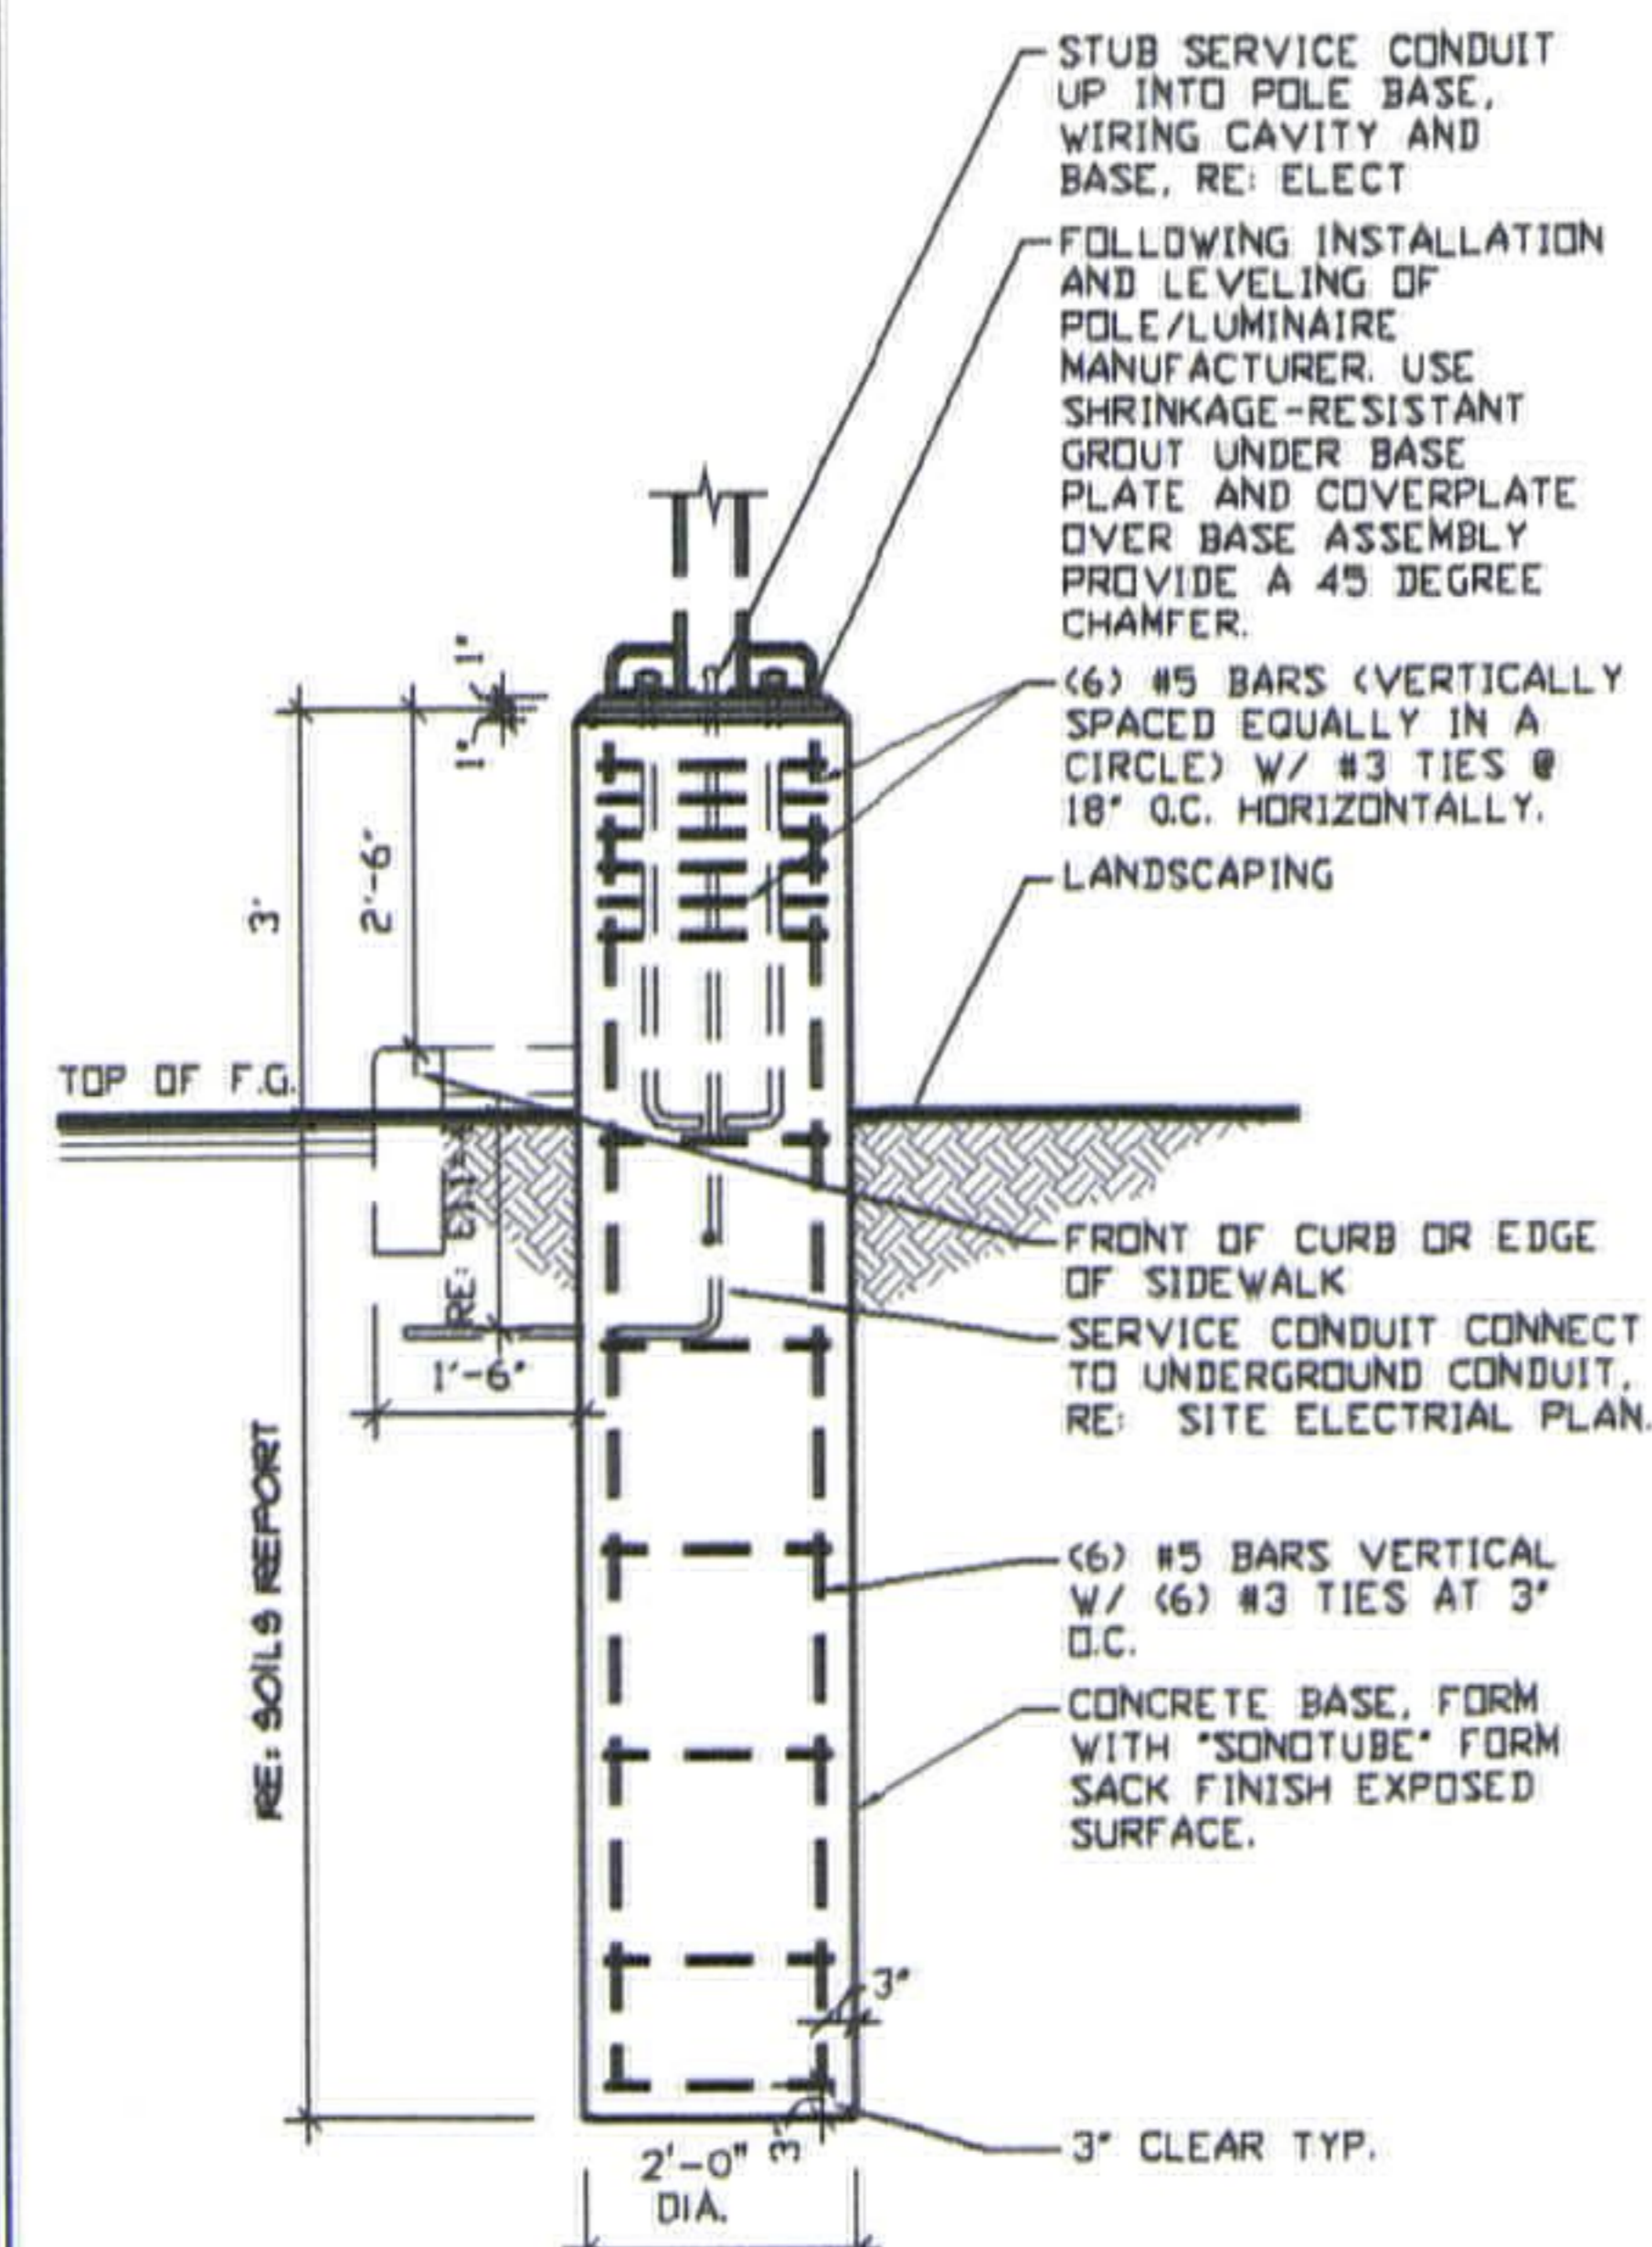

NOTES:

- INSTALL POLE BASE IN NATURAL UNDISTURBED SOIL OR APPROVED COMPACTED FILL PER SOILS REPORT.


16 BASE FOR LIGHT STANDARD

RE: 20/E-2

SCALE: 1/2"=1'-0"

LOT 8 HARMONY SAFEWAY MARKETPLACE

LOCATED IN THE SOUTHWEST QUARTER OF SECTION 31, TOWNSHIP 7
 NORTH, RANGE 68 WEST OF THE 6TH PRINCIPAL MERIDIAN, CITY OF FORT
 COLLINS, COUNTY OF LARIMER, STATE OF COLORADO.

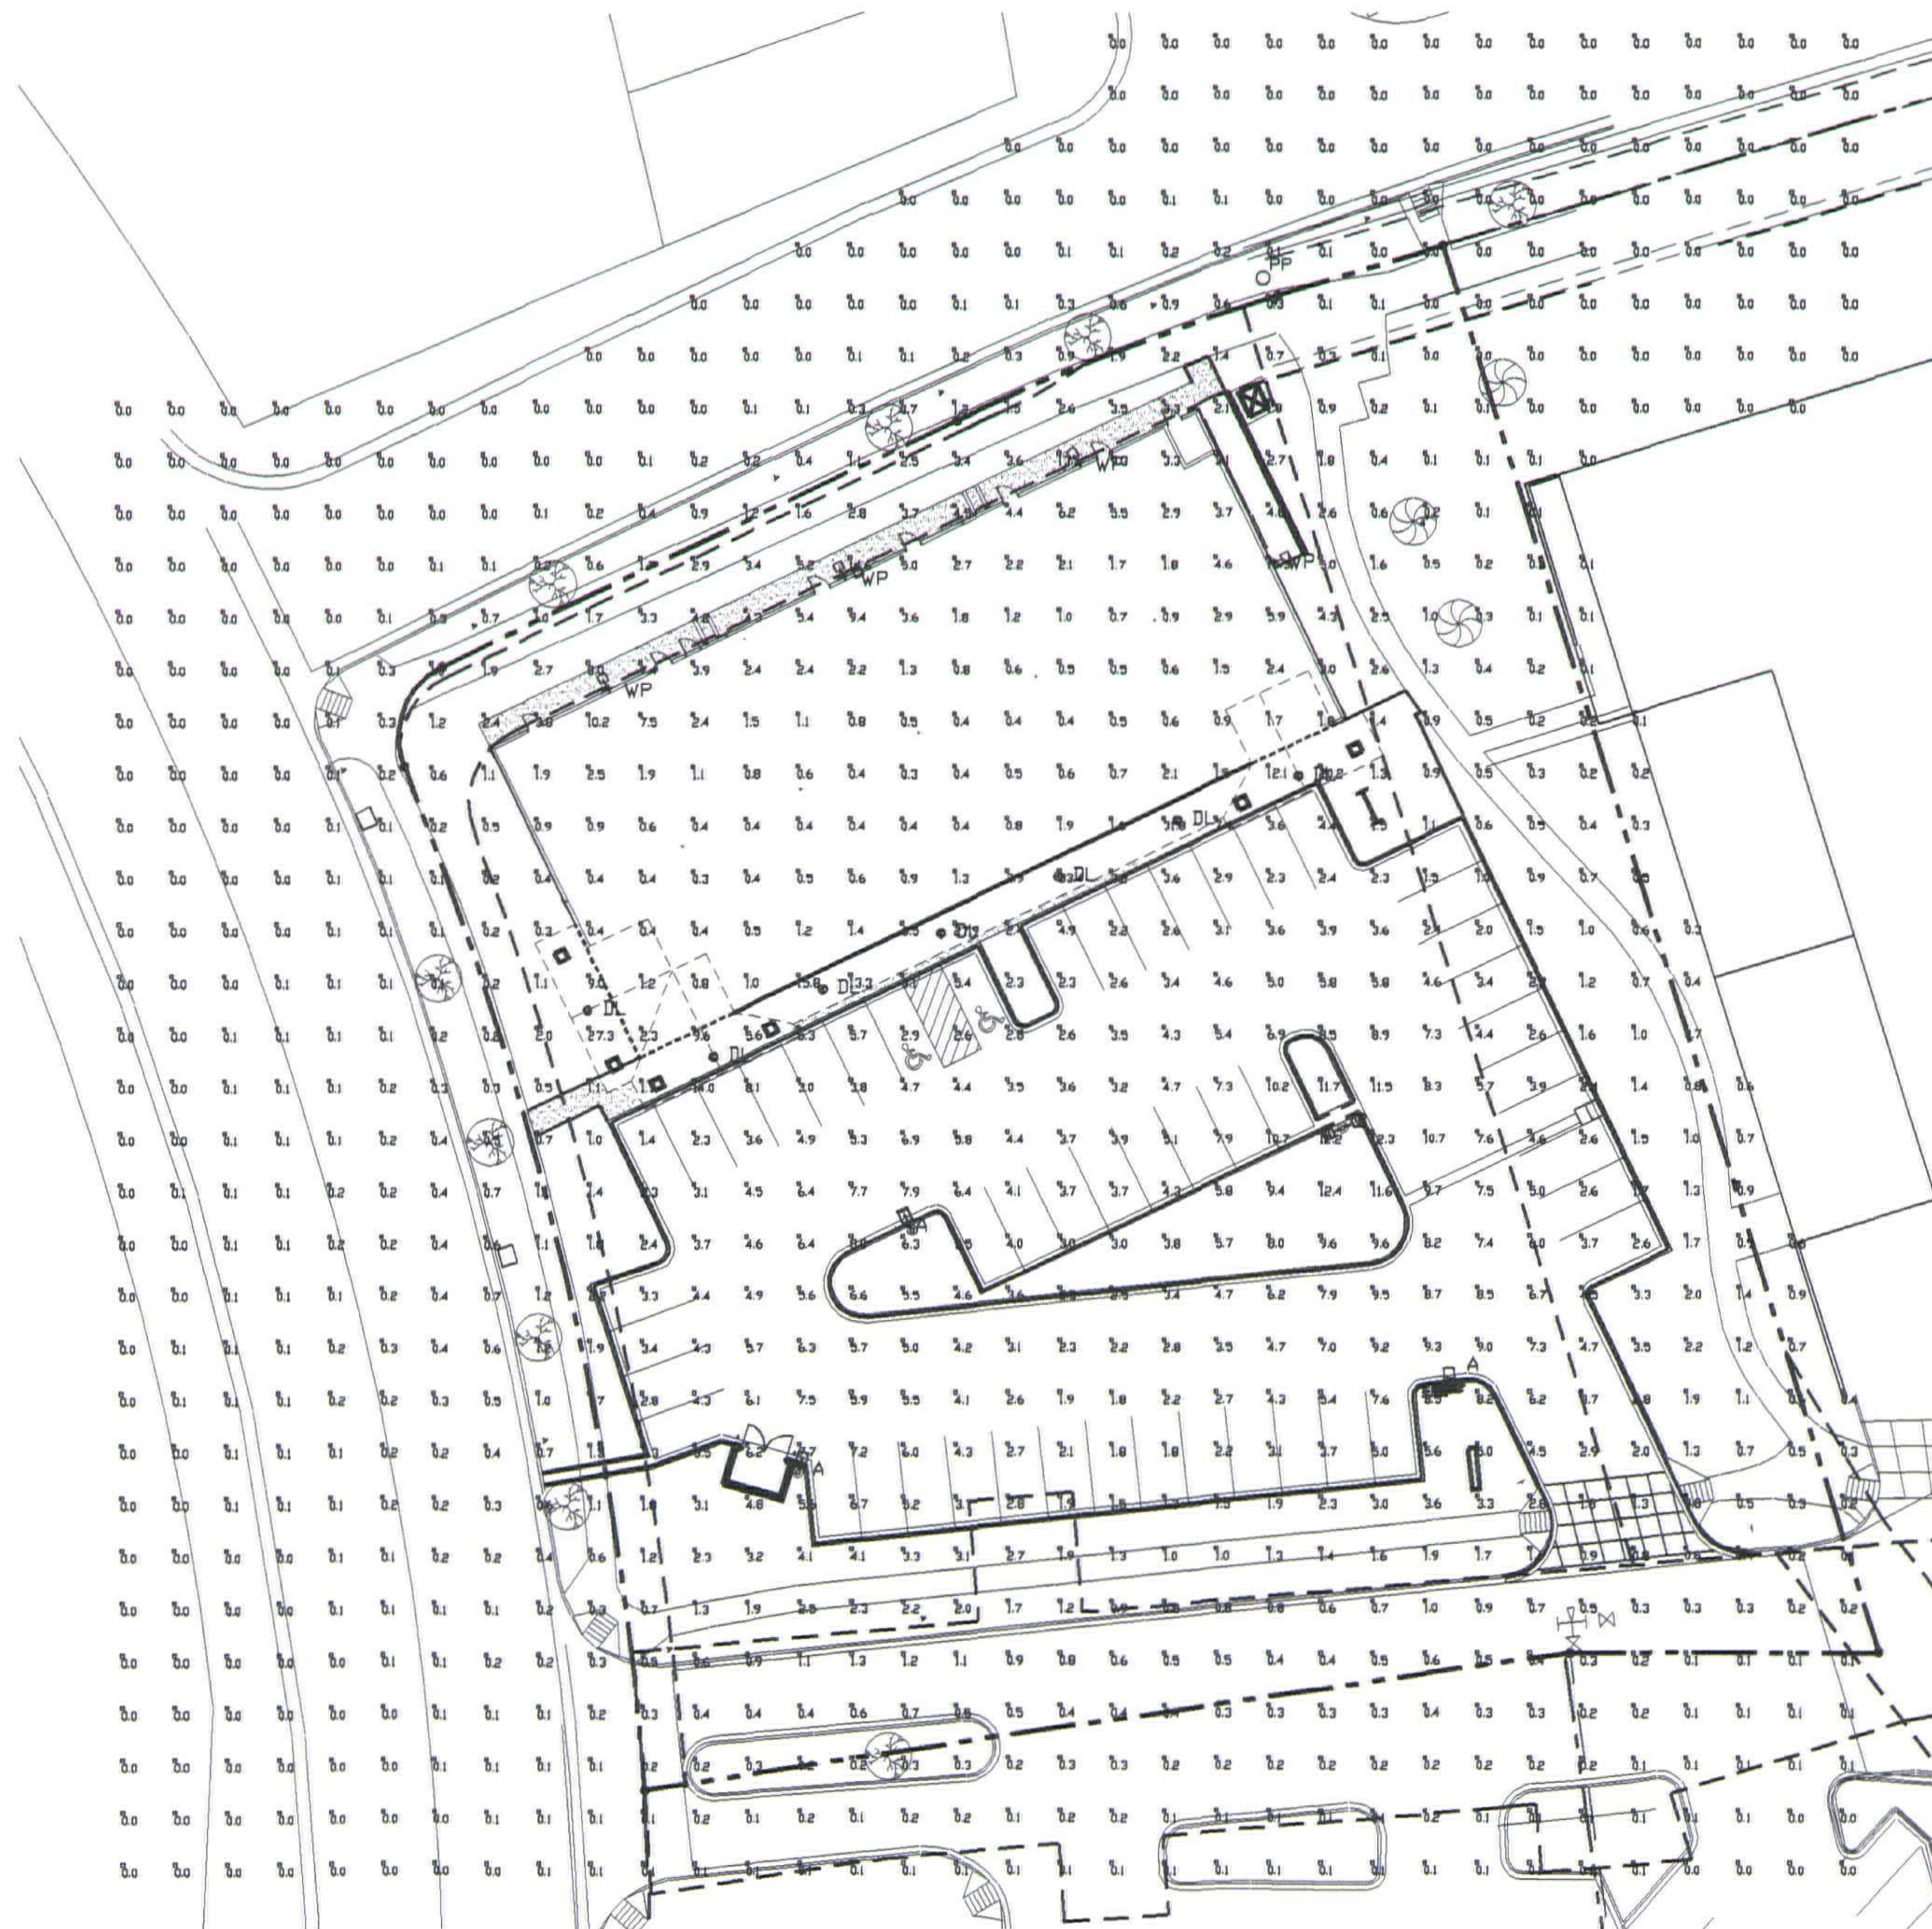

01 PHOTOMETRIC PLAN

SCALE: 1"=20'-0"

NORTH

