


SITE PLAN  
SEWER CONSTRUCTION

SCALE 1" = 30'  
LOT 69  
EAGLE TRAFF  
PROVINCETOWNE PUD

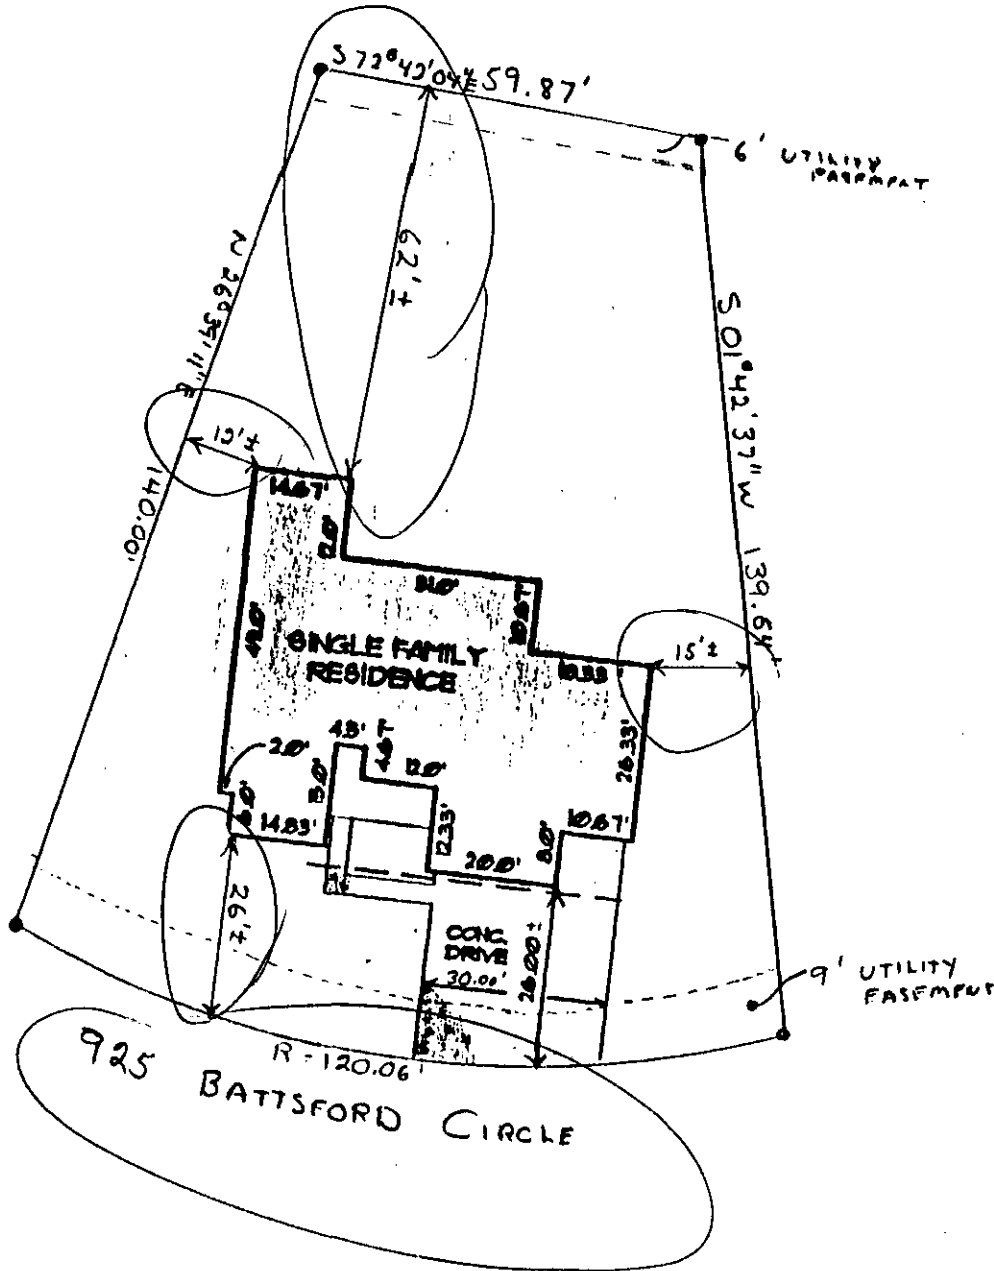

961749

**FOUNDATION CONSULTING ENGINEERS**  
**ENGINEERING**  
 STRUCTURAL FOUNDATION AND SOILS ENGINEERING  
 LOVELAND COLORADO 663-8988

DRAWN BY: ED